


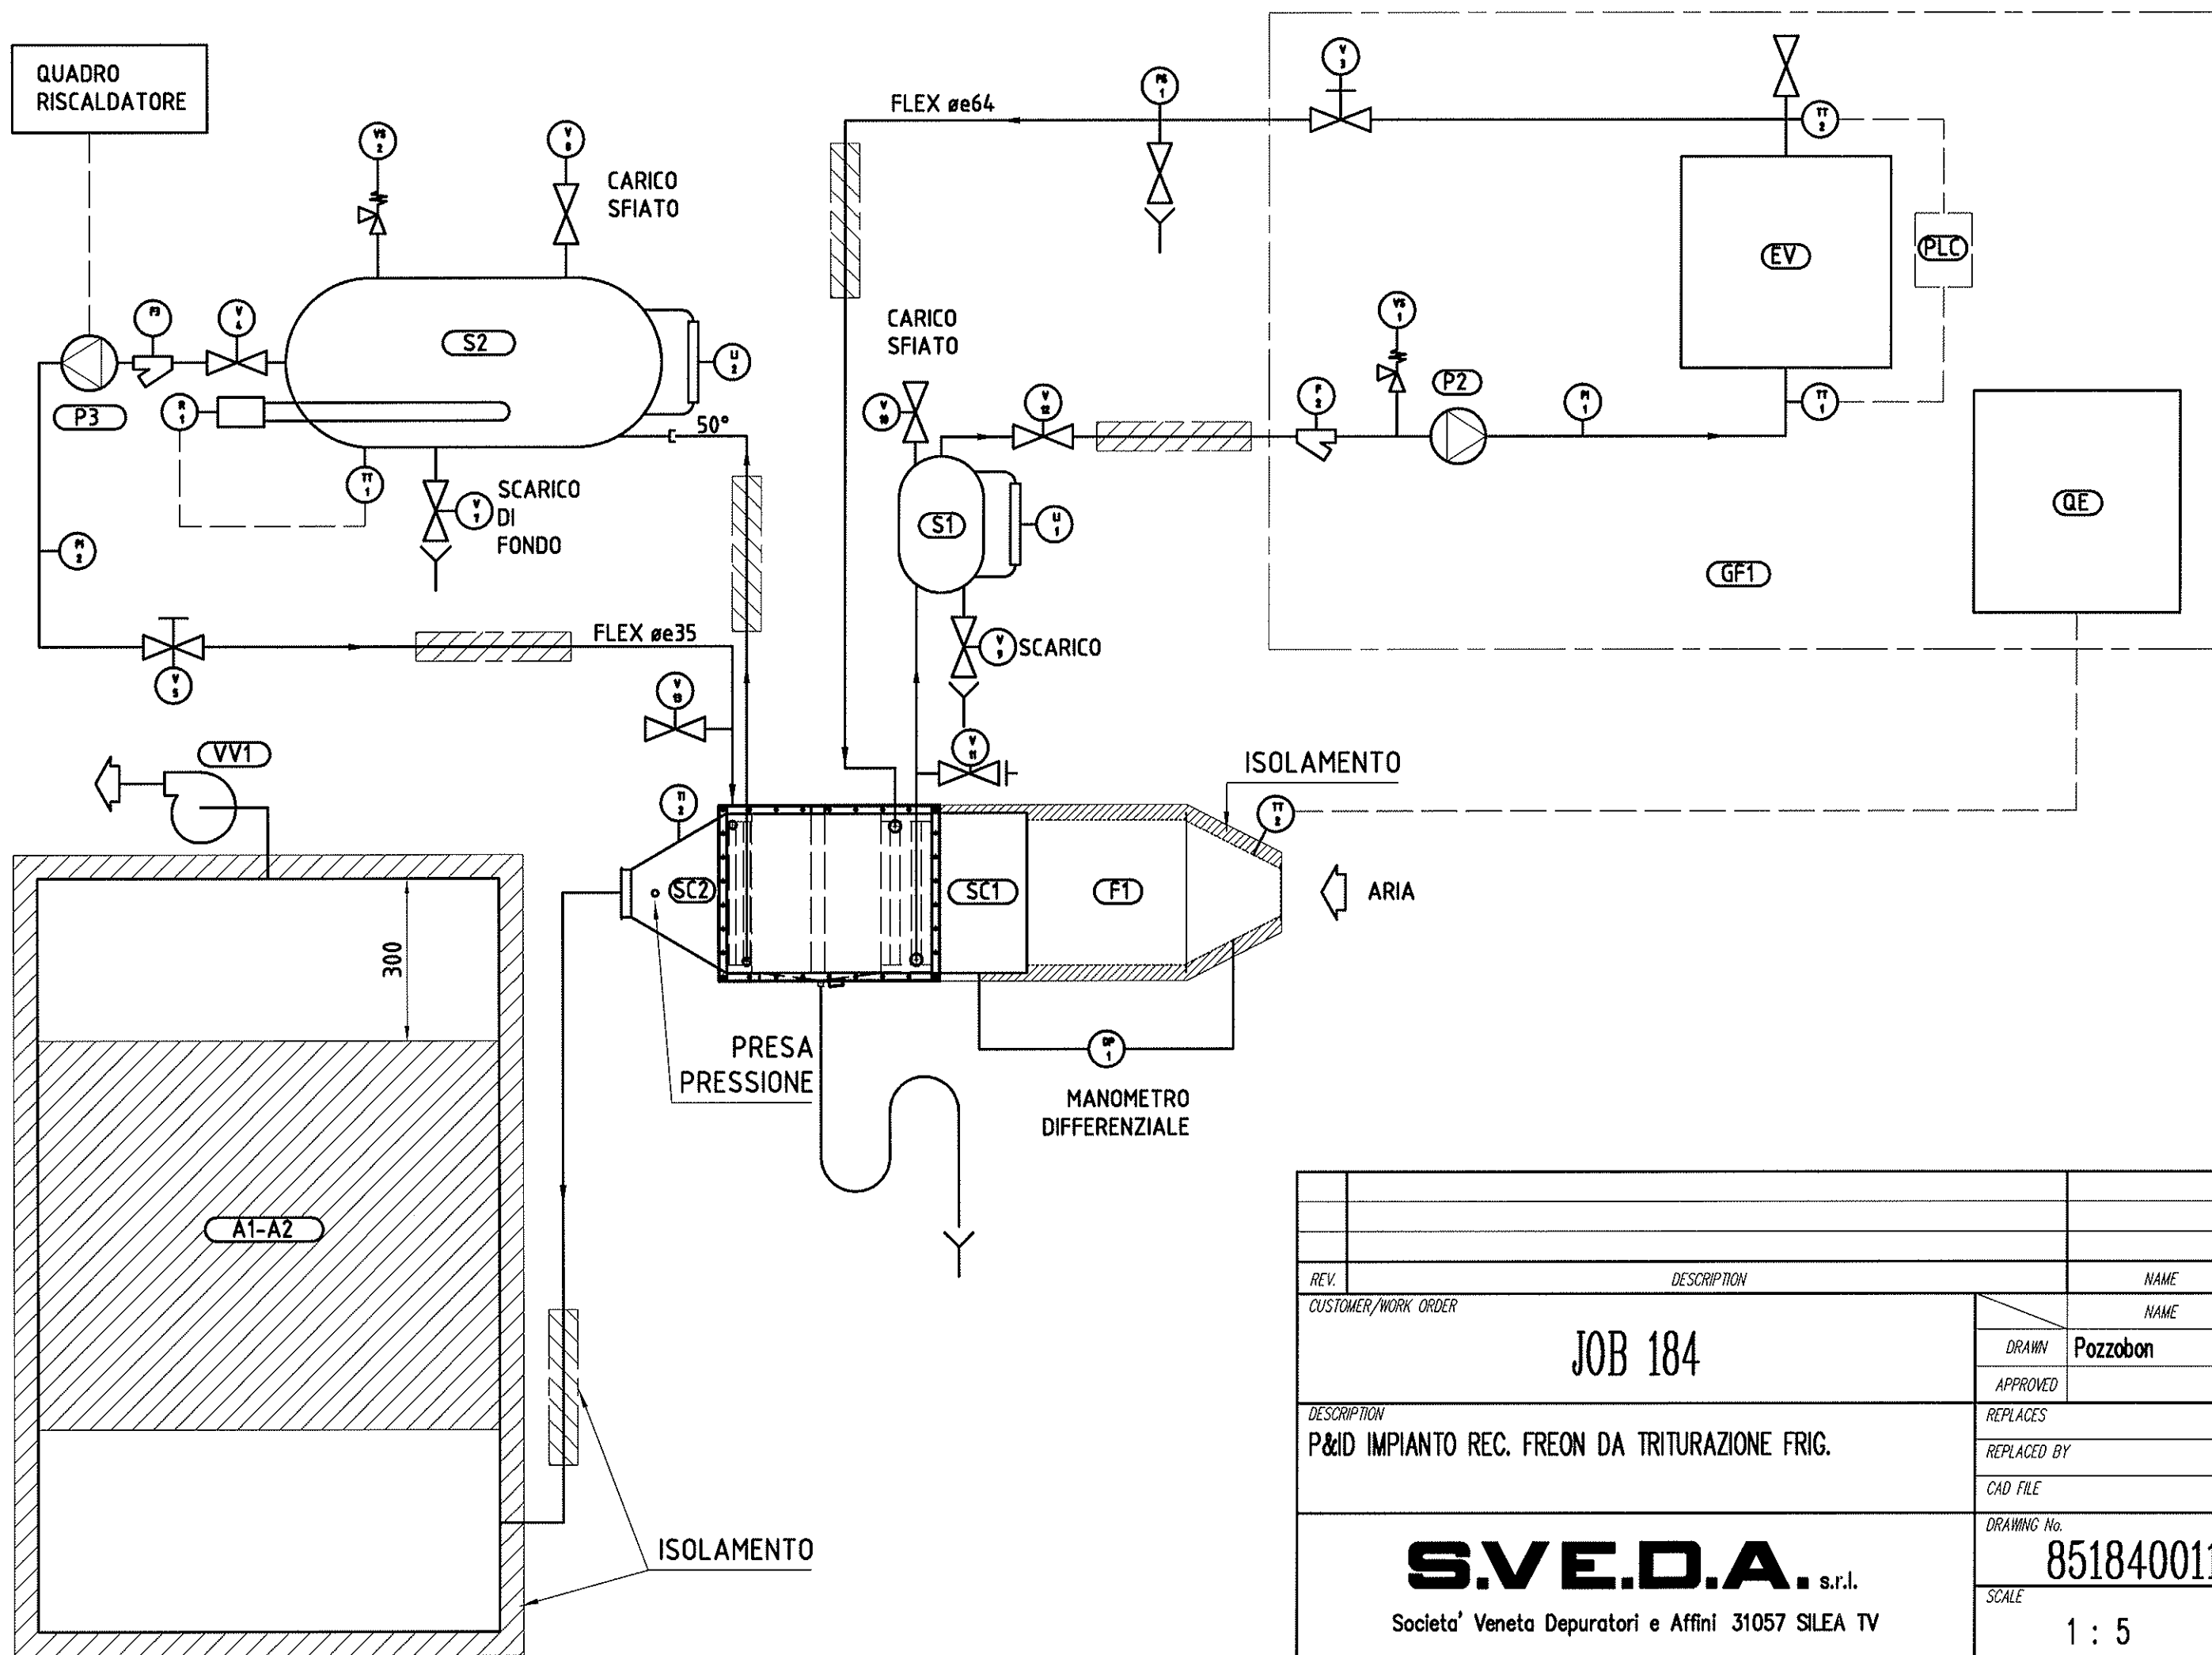

REV.	DESCRIPTION	NAME	DATE
CUSTOMER/WORK ORDER	JOB 184	NAME	DATE
		DRAWN Pozzobon	07.08.2012
		APPROVED	
DESCRIPTION	P&ID IMPIANTO REC. FREON DA TRITURAZIONE FRIG.	REPLACES	
		REPLACED BY	
		CAD FILE	
		DRAWING No.	85184001100C
		SCALE	1 : 5
THIS DRAWING CAN NOT BE REPRODUCED IN ANY FORM WITHOUT OWNER'S PERMISSION			